


UPPER LEVEL ELECT. PLAN

SCALE 3/8" = 1'-0"

ELECT. SYMBOL LEGEND

	110V OUTLET
	220V OUTLET
	GFCI PROTECTED OUTLET
	WEATHER PROOF OUTLET
	SMOKE DETECTOR
	STANDARD LIGHT FIXTURE
	RECESSED CAN LIGHT
	WALL LIGHT FIXTURE
	FLOODLIGHT ASSEMBLY
	SWITCH
	3-WAY SWITCH
	EXHAUST FAN
	THERMOSTAT
	ETHERNET JACK
	TELEPHONE JACK

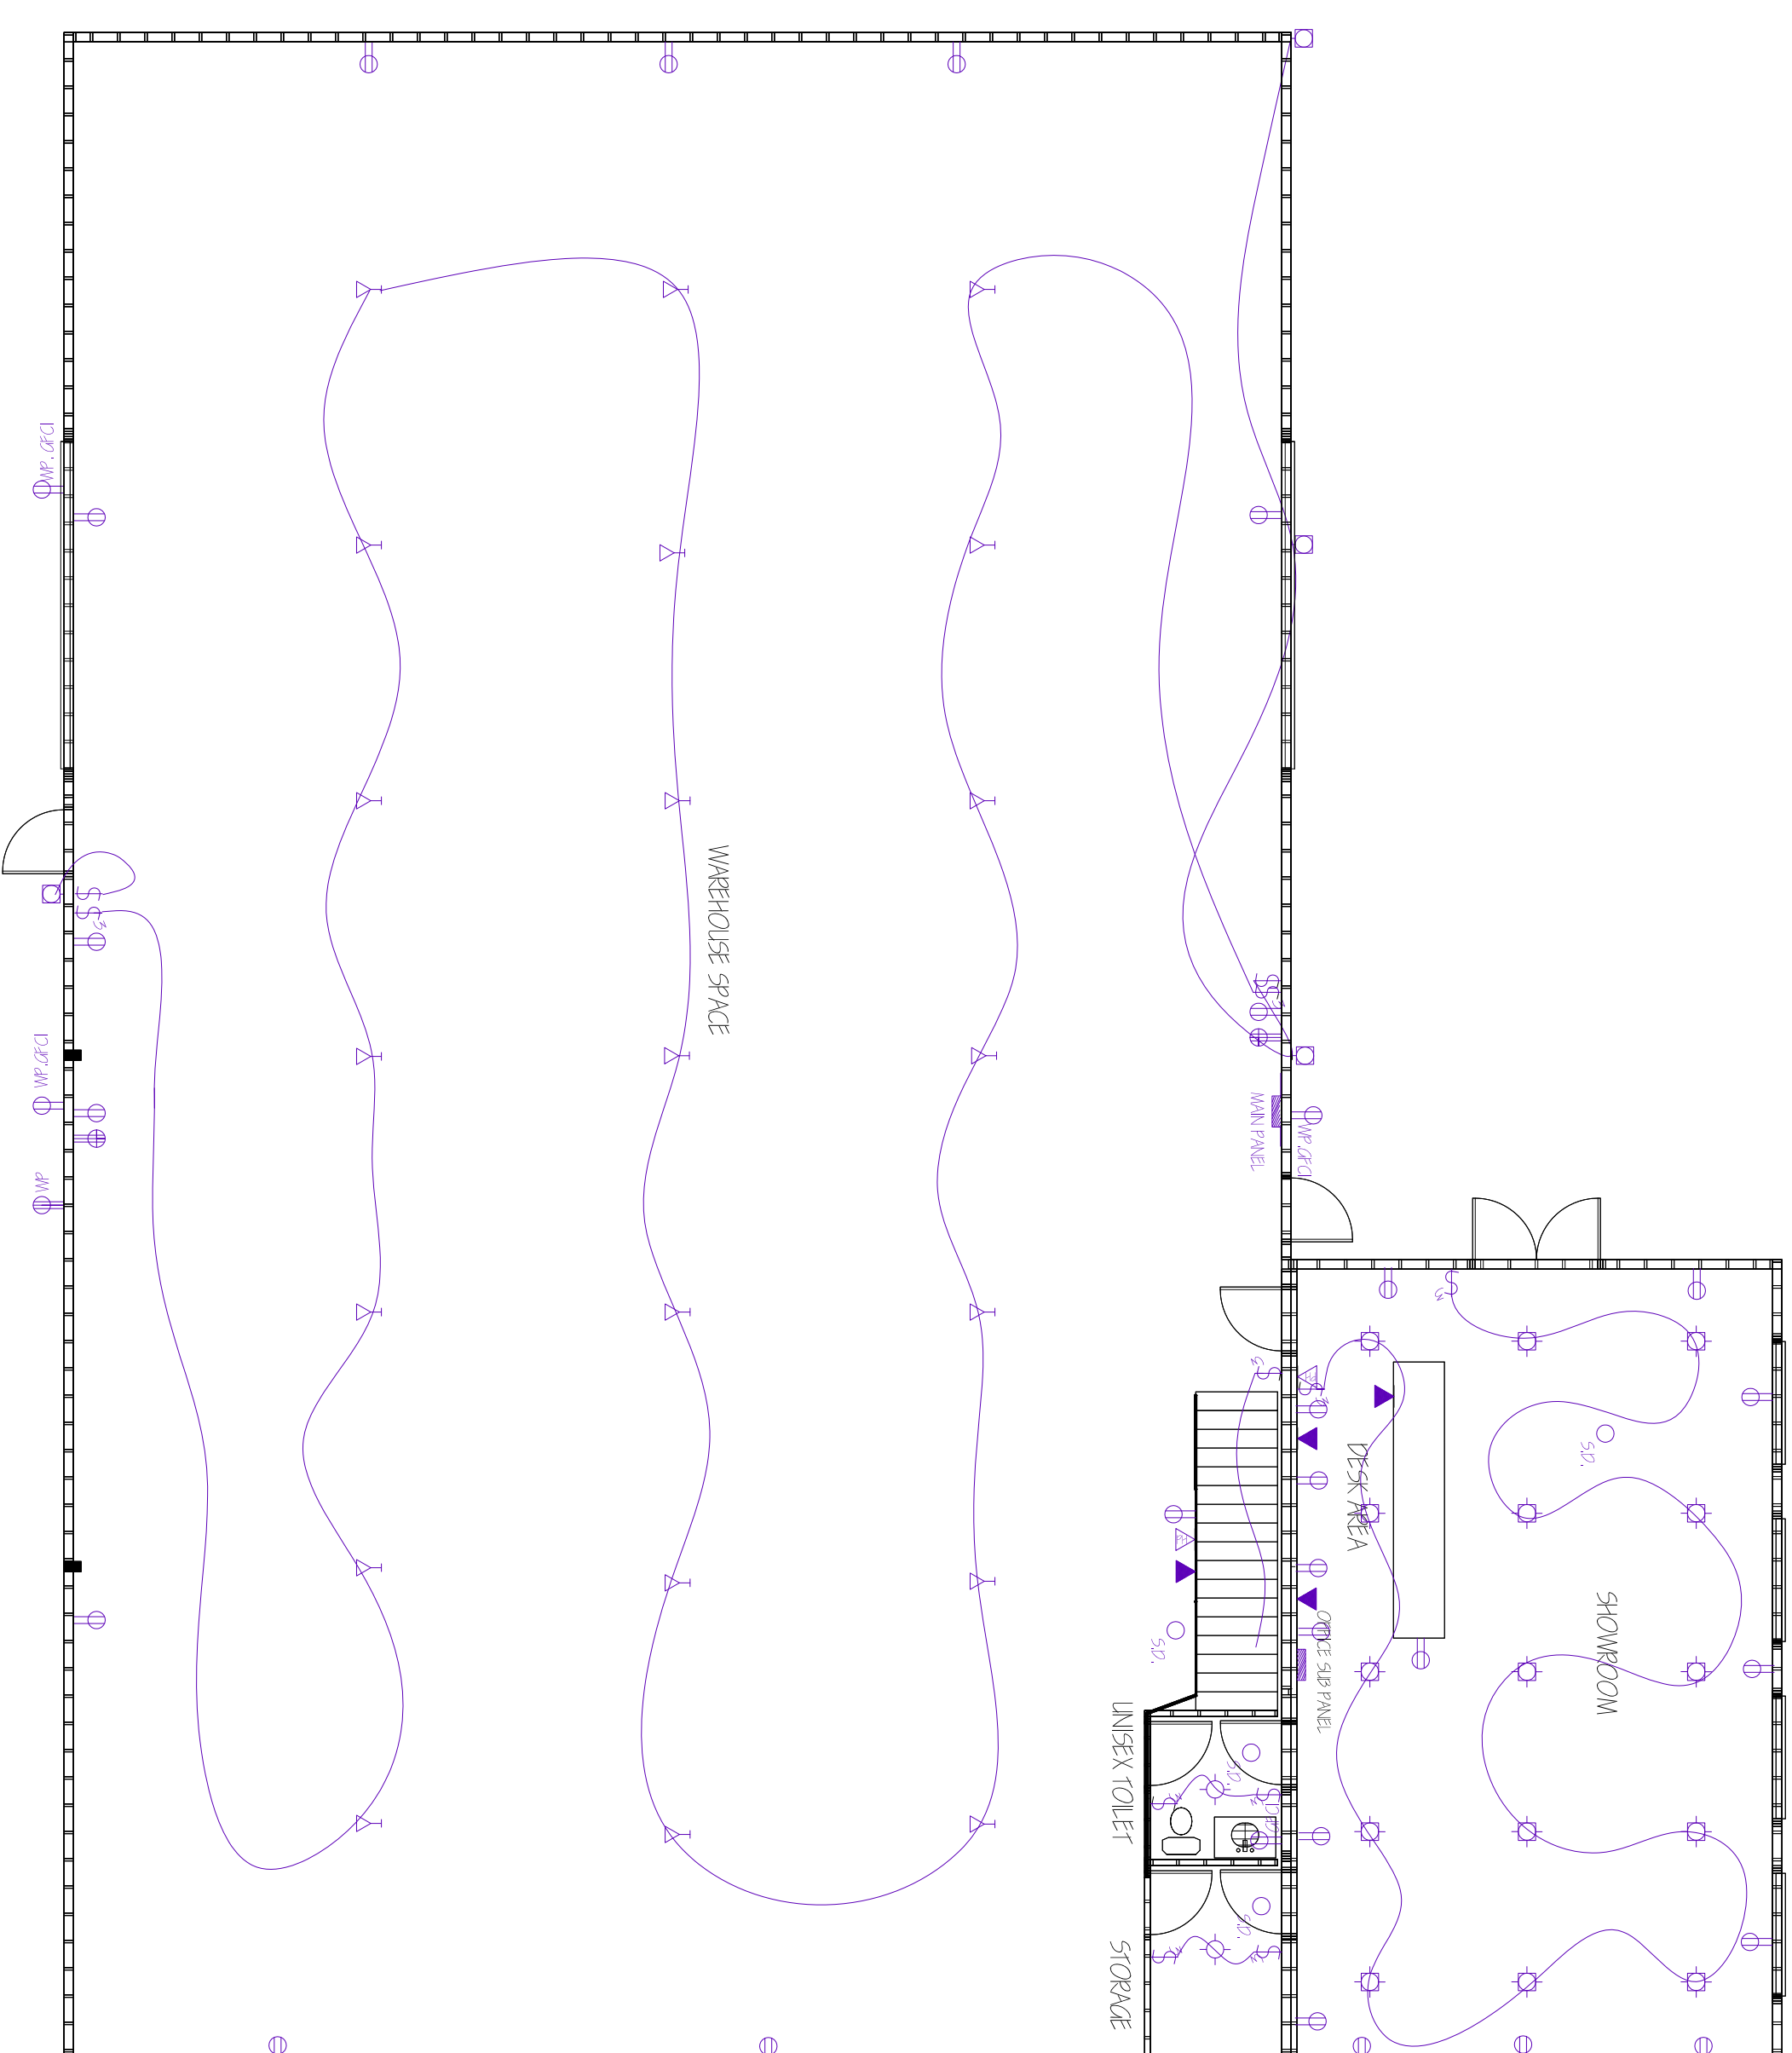

MAIN LEVEL ELECT. PLAN

SCALE 3/8" = 1'-0"

ELECTRICAL NOTES:

- CONFIRM LOCATION OF PHONE, TELEPHONE AND ETHERNET OUTLETS
- CONFIRM LOCATION OF ALL LIGHT FIXTURES WITH OWNER
- PROVIDE OUTDOOR LIGHTING AND OUTLETS AS INDICATED ON PLANS
- ALL BOXES FOR CEILING FANS MUST BE RATED FOR SUCH USE
- FOR BID CONFIRM ALL ELECTRICAL
- 120 VOLT SMOKE DETECTOR REQUIRED ON EACH FLOOR LEVEL. ALL INTERCONNECTED AND LOCATED AS NOTED ON PLANS
- INSTALL GFCI AND WATERPROOF PROTECTED OUTLETS AS INDICATED ON PLANS
- CONTRACTOR SHALL COMPLY WITH ALL LOCAL AND STATE BUILDING CODES AND THE 2002 NEC

ATTENTION!

IT IS IMPORTANT FOR THE GENERAL CONTRACTOR TO UNDERSTAND THAT IT IS HIS/HER RESPONSIBILITY TO BE SURE THIS PROJECT IS CONSTRUCTED IN FULL COMPLIANCE WITH ALL STATE AND LOCAL CODES AND ORDINANCES. THE PLANS ARE NOT ALL INCLUSIVE OF ALL MINIMUM CODES AND ORDINANCES. THIS FACT DOES NOT RELIEVE THE CONTRACTOR FROM COMPLIANCE WITH ALL MINIMUM STANDARDS. NO OMISSION FROM THESE PLANS GIVES PERMISSION FOR VIOLATION OF ANY CODE OR ORDINANCE. APPROVAL EVER GRANTS PERMISSION TO VIOLATE ANY CODE OR TOWN ORDINANCE. STATE BUILDING CODES: 2000 IBC, 2000 IRC, 1999 NEC, 2000 IFGC, 2000 IBC, 2000 IFCC, 2000 IECC (MEC) AND ALL UTAH STATE AMENDED CODES. FOR STRUCTURAL ENGINEER, USE 2000 IBC.

THE GREATEST EFFORT HAS BEEN MADE TO DRAW THESE PLANS WITHOUT ERROR. HOWEVER, THERE IS NO GUARANTEE THAT THESE PLANS ARE WITHOUT ERROR. THE DESIGNER AND DRAFTSMAN ARE TO BE HELD HARMLESS OF ANY FINANCIAL LIABILITY RESULTING FROM ERRORS IN THESE PLANS. ANY ONE USING THESE PLANS FOR CONSTRUCTION OF BUILDING, ACCEPTS FULL RESPONSIBILITY. (CHECK PLANS CAREFULLY BEFORE CONSTRUCTION.)

DATE: _____
 05/02/04
 DRAWN BY: SRW
 NOTES: _____

PROJECT: WBS BUILDING

S&N DESIGN
 1857 N 1120 W PROVO, UTAH 84604 (801) 426-8777

SHEET NAME: MAIN AND UPPER LEVEL ELECTRICAL PLANS

SHEET: A-10 OF: A-11